


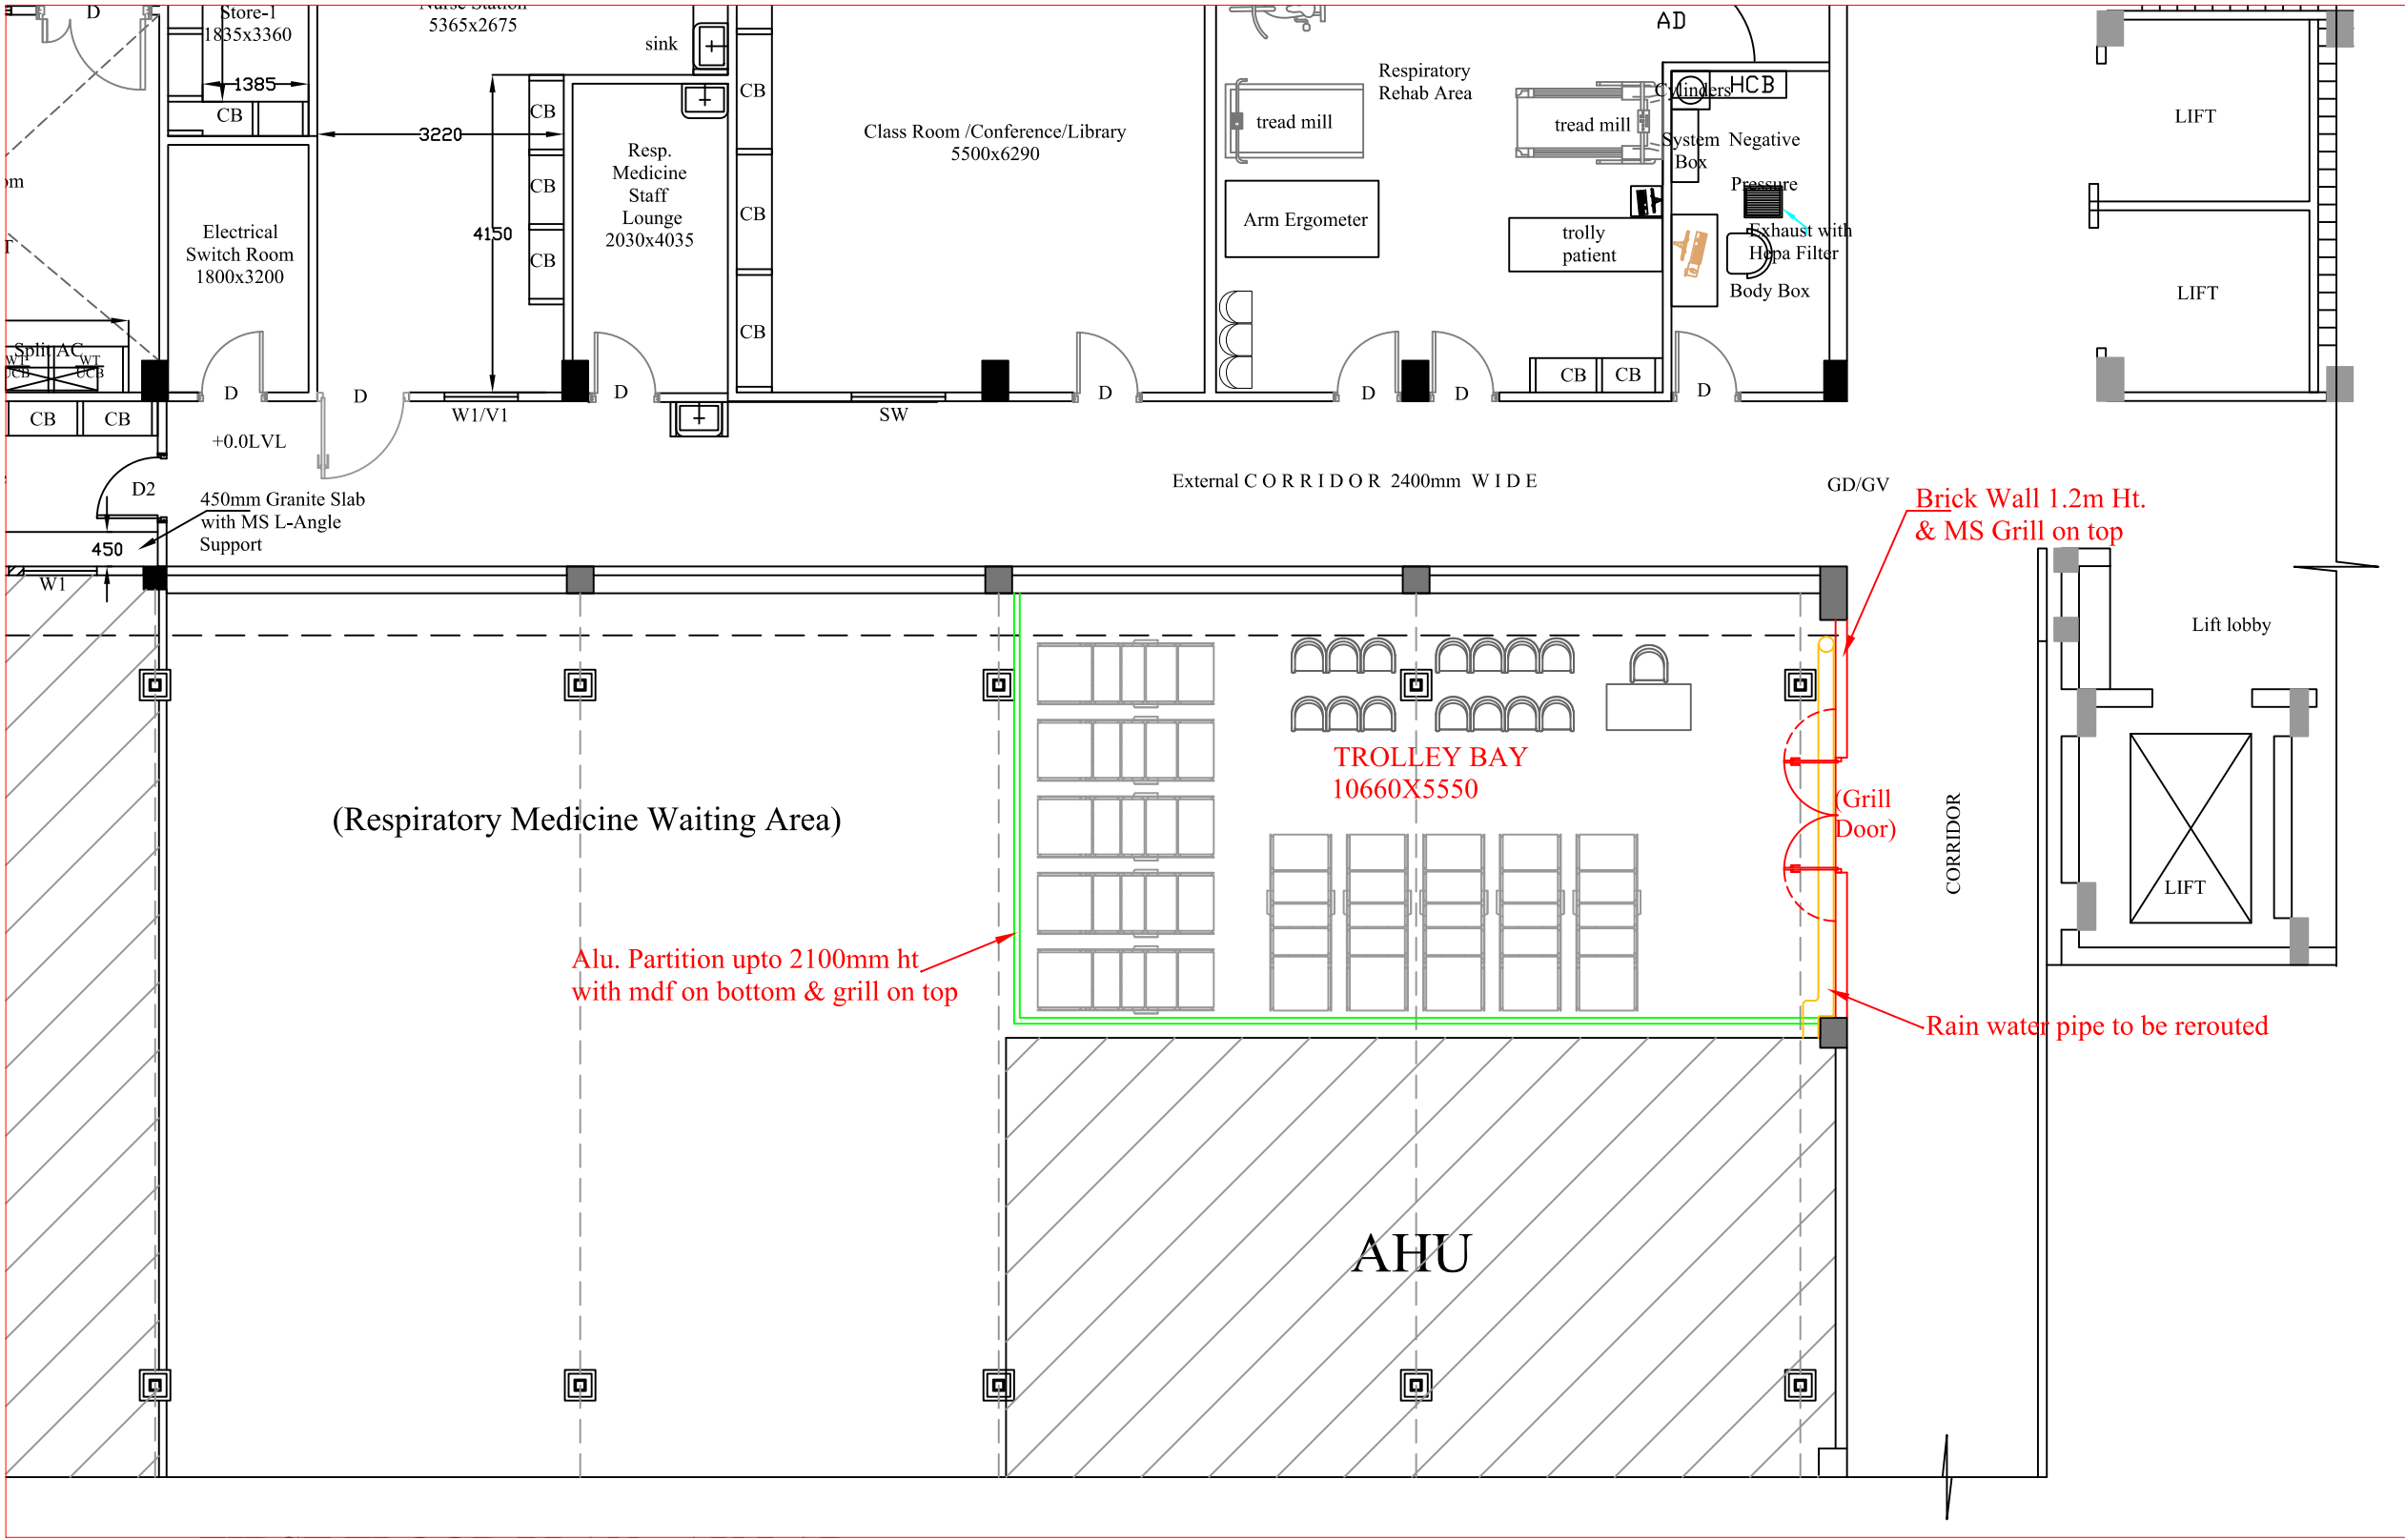

KEY PLAN

- NOTE :**
1. Plug points (5 amps) - 5 to 6 nos.
 2. Ceiling fan - 4 nos.

NEAR O1 WEST - FIRST FLOOR PROPOSED PLAN

JOINERY DETAILS

NOTATION	DESCRIPTION	SIZE OF OPENING	SILL	LINTEL
GD	GRILL DOOR	1500 X 2100	-	2100


REFERENCE:

PROPOSED WORK SHOWN THUS
EXISTING SHOWN IN
ALUMINIUM PARTITIONS SHOWN IN



NOTE :

1. All Dimensions are MM.
2. Dimensions should be Re-checked at site.
3. Work to figured Dimensions, Do not scale this drawing.
4. Discrepancies if any should be brought to the notice of the engineer.

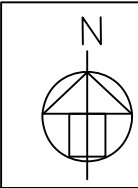

TENDER PURPOSE ONLY	
CHRISTIAN MEDICAL COLLEGE VELLORE.	
PROPOSED TROLLEY BAY FOR OR TROLLEYS NEAR O1 WEST & Q2 BLOCK AT CMC TOWN CAMPUS	
FIRST FLOOR PLAN (PROPOSED)	
CHKD BY:DEVAKI.G	DATE : 06.01.2026
DRAWN: DAVID ANDREW	DRG.NO:CMC/TB/ORT/A02