


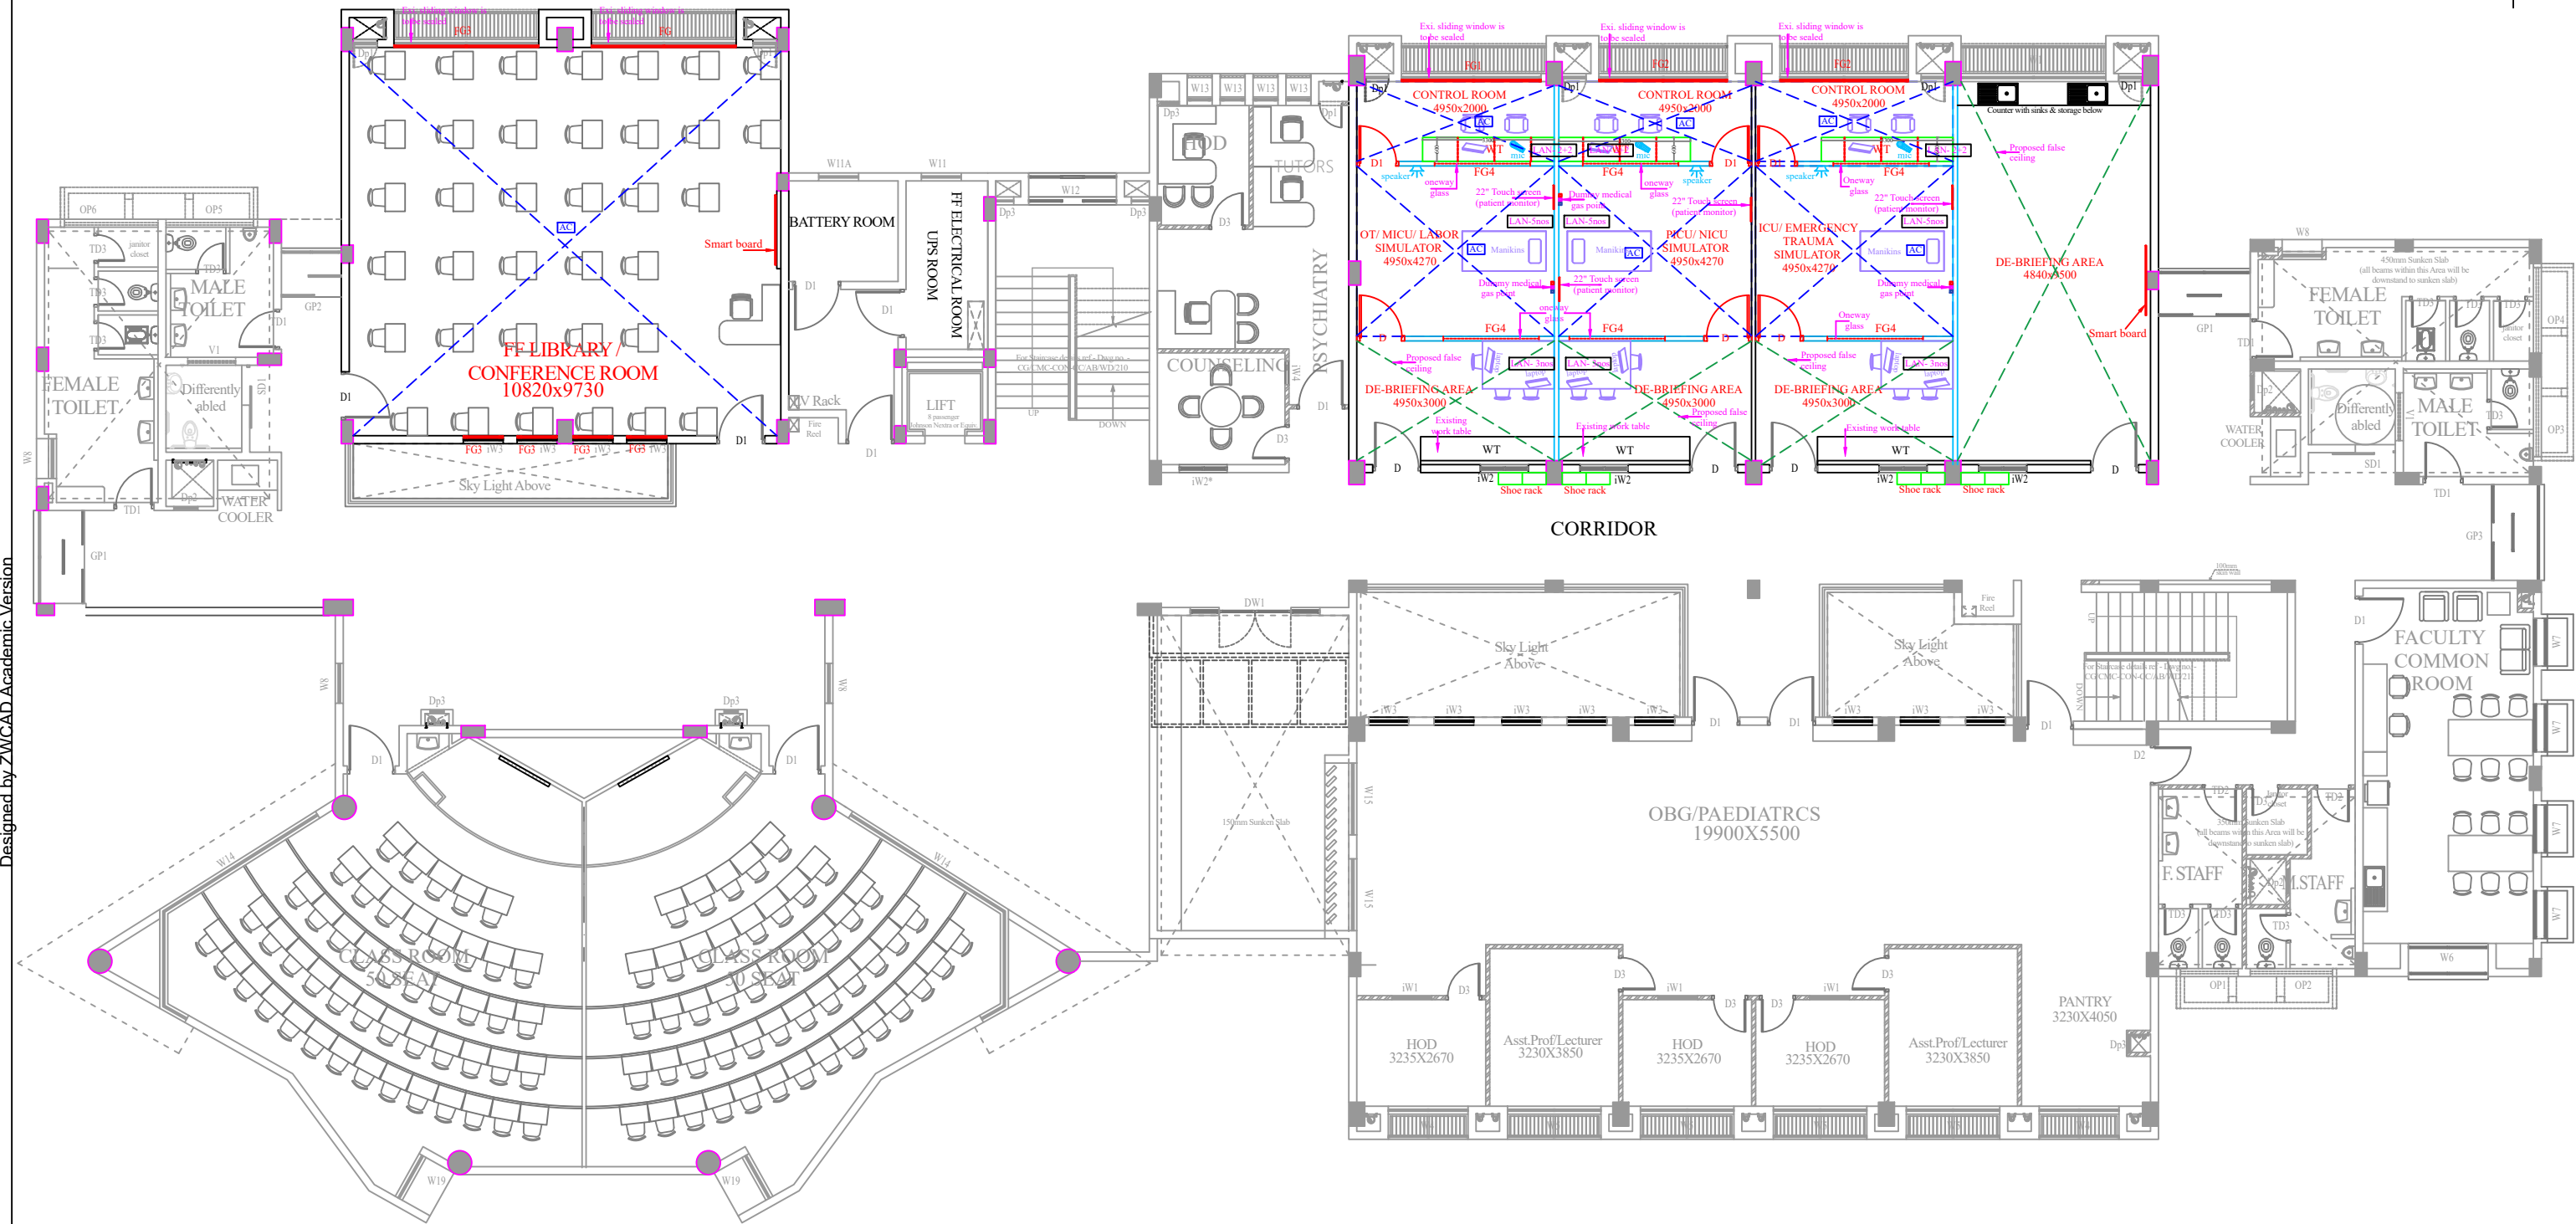

EXISTING SHOWN IN	
PROPOSED SHOWN IN	
115mm thk.DRY WALL PARTITION UPTO CEILING HT. SHOWN IN	
PROPOSED AC WITH FALSE CEILING	
PROPOSED FALSE CEILING WITH NO AC	
MODULAR FURNITURE SHOWN IN	
NOTE: 1. All Dimensions are in MM. 2. Dimensions should be Re-checked at site. 3. Work to figured Dimensions, Do not scale this drawing. 4. Discrepancies if any should be brought to the notice of the engineer.	

CEILING HEIGHT - 3.340M
BEAM BOTTOM - 2.750 M

TENDER PURPOSE ONLY		
CHRISTIAN MEDICAL COLLEGE - VELLORE		
PROPOSED SIMULATION LABS AND CONFERENCE HALL ON THE FIRST FLOOR OF COLLEGE OF NURSING AT CMC CHITTOOR CAMPUS		
FIRST FLOOR PLAN - PROPOSED		
DATE : 30.01.2026	DRG.NO. : CMC/SIMLAB/A-002	PLANNING ENGINEER:
DRAWN : YAMUNA	CHECKED : DEVAKI	