




FINISHING SCHEDULE

ROOM NAME	FLOOR FINISH	WALL FINISH	CEILING
Toilet/Sluice	TILE	Wall Tile upto 1500mm & Acrylic Emulsion Painting above upto ceiling	Distemper
Other Areas	TILE WITH SKIRTING	Enamel Paint upto 2100mm & Acrylic Emulsion Painting above upto ceiling	Distemper

JOINERY:

DOOR.....D: 1200x2100
 DOOR.....D1: 900x2100
 DOOR.....D2: 860x2100
 OPEN.....OP1: DOOR OPENING
 OPEN.....OP: ABOVE THE LINTEL LEVEL

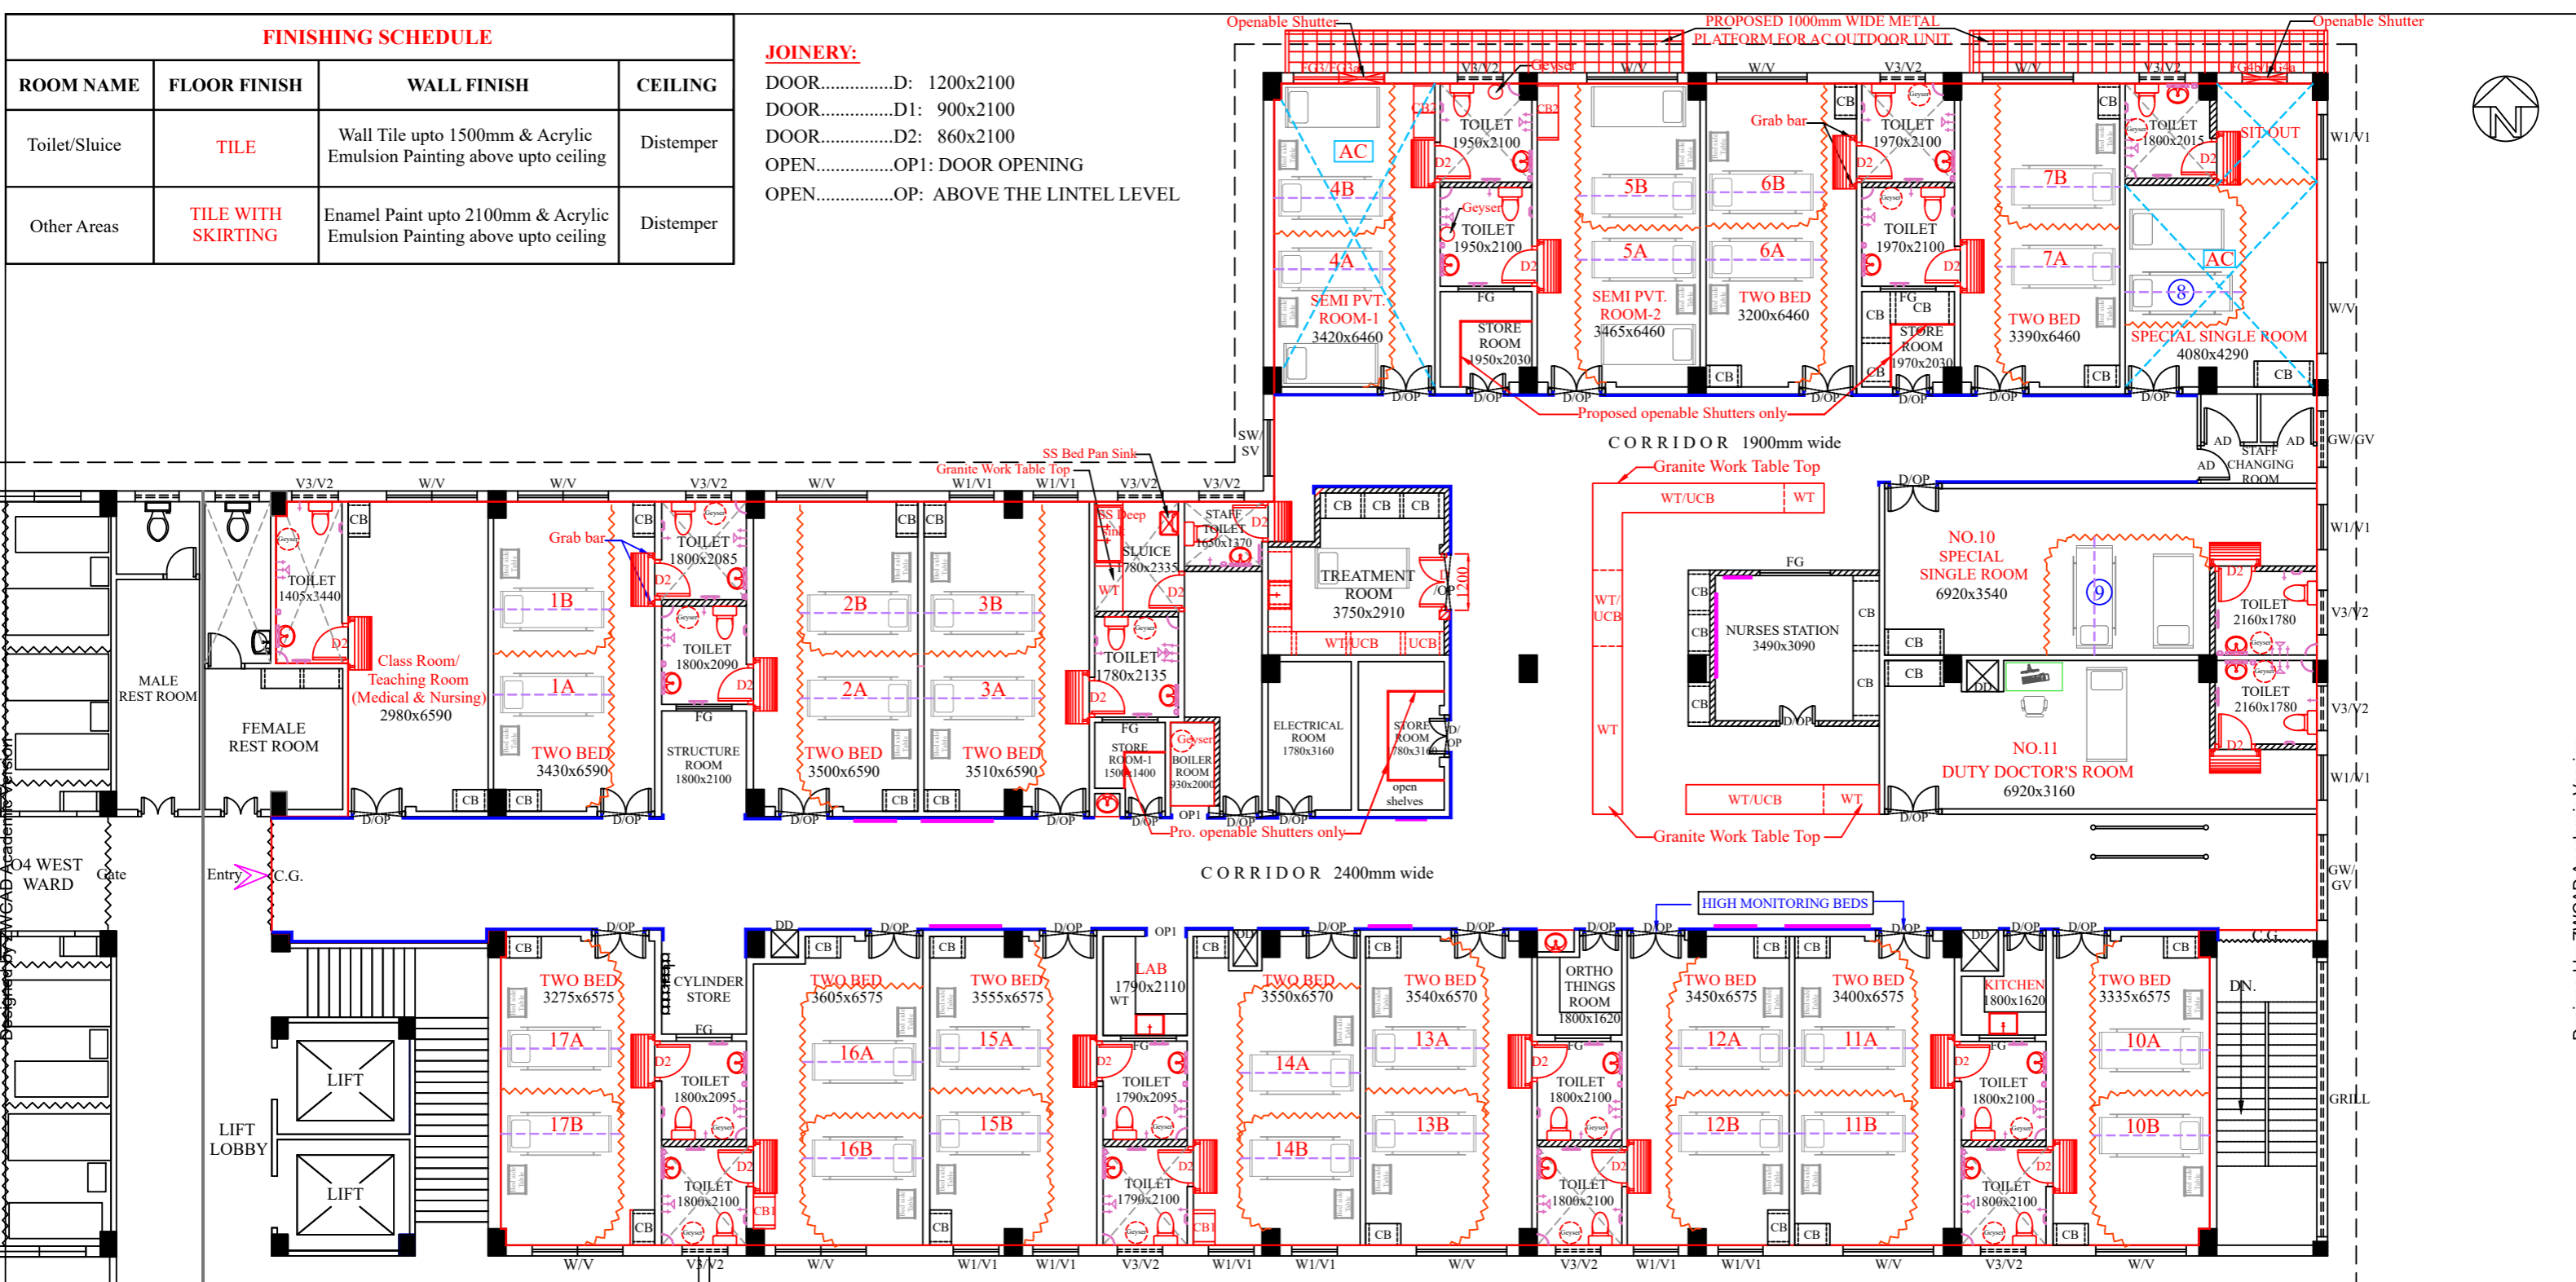

'O4' EAST WARD - FOURTH FLOOR PLAN (Infectious Diseases Ward)

AREA: 833.0sq.m./ 8965.0sq.ft. No. of Beds: 32

NOTE:

- I. COMMUNICATION:**
 - * One Parallel Telephone Connection in the Corridor (in between Room 2 and 3)
- II. ELECTRICAL:**
 - * 5 AMS plug (5) in room 11 and 12 (high monitoring rooms) between the beds.
 - * Plug points for induction stove in pantry.
 - * Fan in patient waiting area.
- III. MED:**
 - * ONE OXYGEN AND SUCTION PORT IN ROOM (In addition to Existing one in each room)
 - * Geyser in single rooms.
- IV. CIVIL:**
 - * PROPOSED GRAB BARS AT THE TOILET DOOR STEPS/RAMPS
- V. BIO-MEDICAL:**
 - * WALL-MOUNTED MONITORS IN BED NO. 11 & 12
- VI. AIR-CONDITION :**
 - * AIR-CONDITION ROOM NO. 4 AND 8.

REFERENCE:

- MODIFICATION SHOWN IN.....
- IV TRACK SHOWN IN.....
- PRO. FAST-TRACK CURTAIN TRACKS SHOWN IN.....
- PROPOSED CORNER GUARDS/ WALL STRETCHER GUARDS SHOWN IN.....
- NOTICE BOARD / DISPLAY BOARD / WHITE BOARD AND ROSTER SHOWN IN.....
- MODULAR FURNITURE SHOWN IN.....
- EXISTING SHOWN IN.....
- AIR CONDITION SHOWN IN.....

All Dimensions are in Millimetre.

TENDER PURPOSE ONLY

CHRISTIAN MEDICAL COLLEGE -VELLORE.

MODIFICATION TO EXISTING O4 EAST WARD IN FOURTH FLOOR OF 'O' BLOCK AT CMC TOWN CAMPUS.

O4 EAST WARD - FOURTH FLOOR - PROPOSED PLAN

CHKD BY: A.K.	DATE : 12.05.2026	PLANNING ENGINEER:
DRAWN: M.B.	DRG.NO:CMC/O4E/A-02	