



LEGEND

	Smoke Detector
	Hooter
	Manual Call Point
	Fire Alarm Panel
	Sprinkler

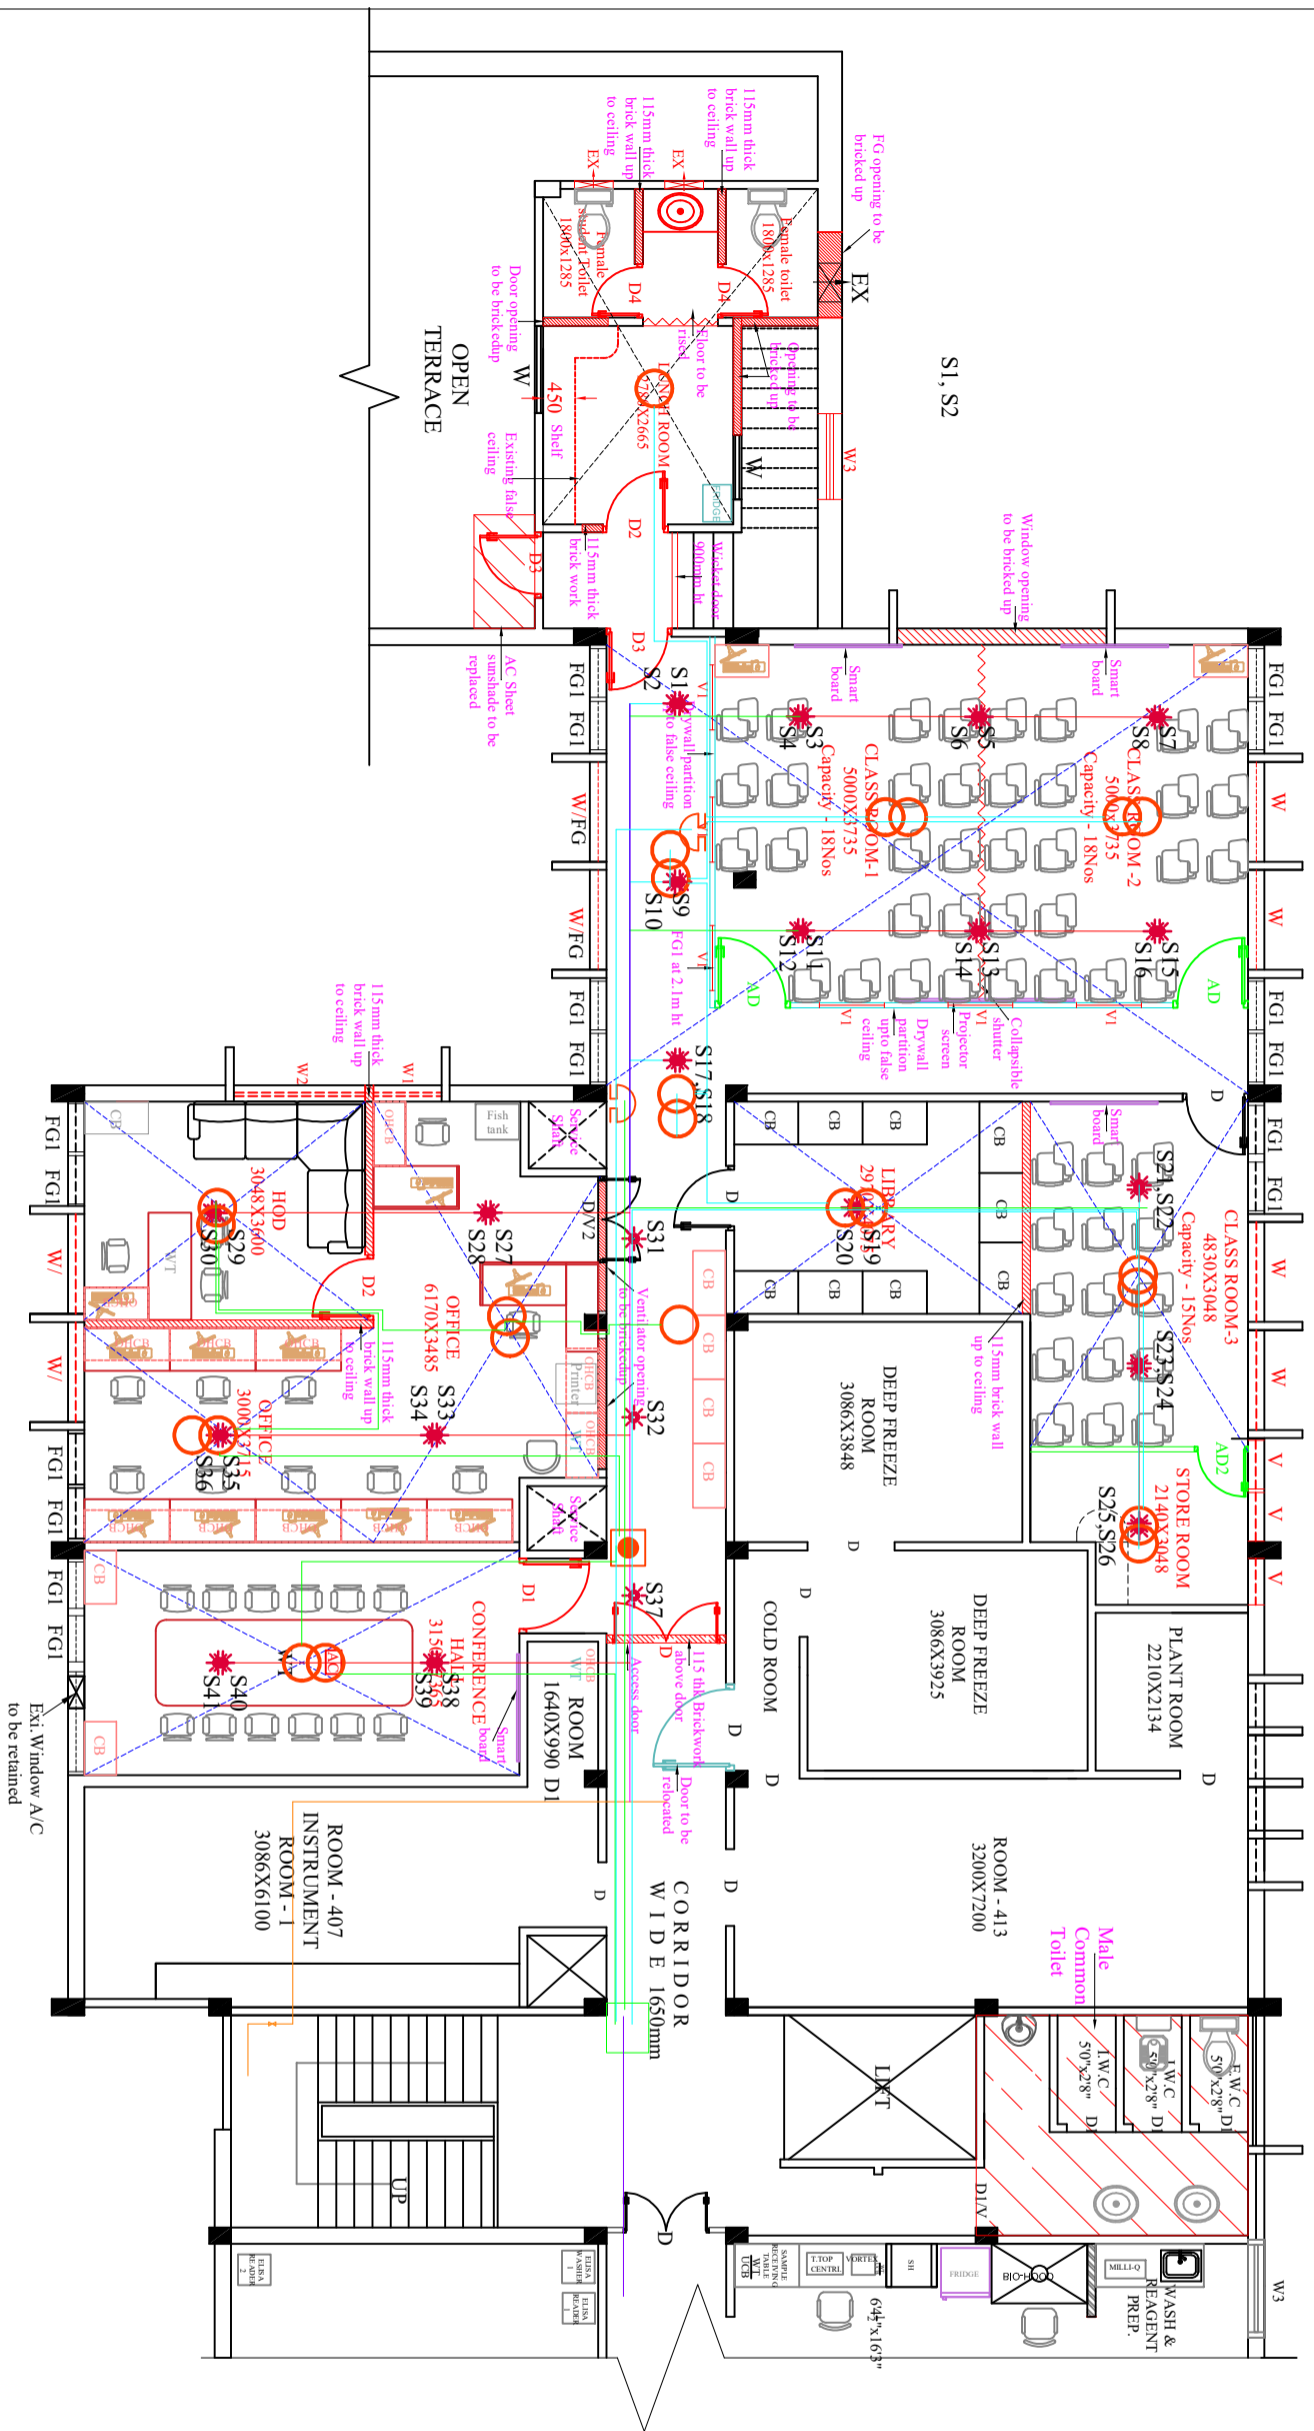

Third Floor Key Plan

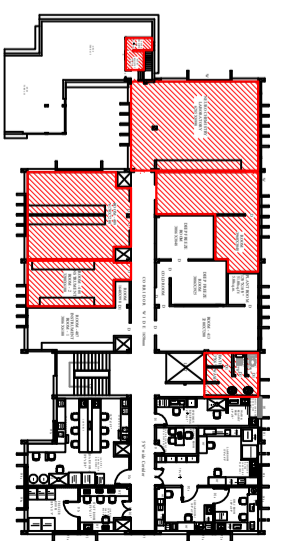

- NOTE:**
1. All Dimensions are in MM.
 2. Dimensions should be Re-checked at site.
 3. Work to figured Dimensions. Do not scale this drawing.
 4. Discrepancies if any should be brought to the notice of the engineer.

REFERENCE:

	PROPOSED SHOWN IN
	EXISTING SHOWN IN
	11.5mm THICK BRICKWORK SHOWN IN
	MODULAR FURNITURE SHOWN IN
	FALSE CEILING SHOWN IN
	ALUMINIUM PARTITION SHOWN IN
	REMOVING AND RELINING SHOWN IN
	DRY WALL PARTITION SHOWN IN

FINISHING SCHEDULE

ROOM NAME	FLOOR FINISH	WALL FINISH	CEILING
CONFERENCE ROOM	VINYL FLOORING	ACRYLIC EMULSION PAINT.	FALSE CEILING
OFFICE AREA	VINYL FLOORING	ACRYLIC EMULSION PAINT.	FALSE CEILING
HOD ROOM	VINYL FLOORING	ACRYLIC EMULSION PAINT.	FALSE CEILING
CLASSROOMS	GRANO FLOORING TO BE POLISHED	ACRYLIC EMULSION PAINT.	FALSE CEILING
LUNCH ROOM	GRANO FLOORING TO BE POLISHED	ACRYLIC EMULSION PAINT.	EXISTING FALSE CEILING
TOILET	TILES FLOORING	7-TILES ABOVE	EXISTING FALSE CEILING

SCHEDULE OF OPENINGS

TYPE	WIDTH	HEIGHT	SILL	LINTEL	REMARKS
D	1500	2100	-	2100	WOODEN DOOR DOUBLE SHUTTER
D1	1050	2100	-	2100	WOODEN DOOR SINGLE SHUTTER
D2	910	2100	-	2100	WOODEN DOOR SINGLE SHUTTER
D3	810	2100	-	2100	WOODEN DOOR SINGLE SHUTTER
D4	750	2100	-	2100	TOILET DOOR
AD	1050	2100	-	-	ALUMINIUM SINGLE DOOR
AD2	750	2100	-	-	ALUMINIUM SINGLE DOOR
W	1400	1400	800	2200	NCL WINDOW WITH GRILL
W1	950	1120	800	2200	NCL WINDOW WITH GRILL
W2	1840	1120	800	2200	NCL WINDOW WITH GRILL
W3	1200	1350	-	-	NCL WINDOW WITH GRILL
V	650	600	-	-	NCL VENTILATOR WITH MESH
V1	910	600	-	-	NCL VENTILATOR WITH MESH

FOR ESTIMATION PURPOSE

CHRISTIAN MEDICAL COLLEGE-YELLORE
 MODIFICATION OF EXISTING ROOM NO : 408, 409, 410, 411 AND NEURO CHEMISTRY OFFICE TO STAFF TRAINING IN WILLIAMS BUILDING THIRD FLOOR AT CMC TOWN CAMPUS

THIRD FLOOR PLAN (PART) PROPOSED

CHKD BY : DEVAKI	DRAWN : YAMUNA	PLANNING ENGINEER:
DRG.NO : CMC/CWB/3RD/ST-002	DATE : 19.01.2026	