


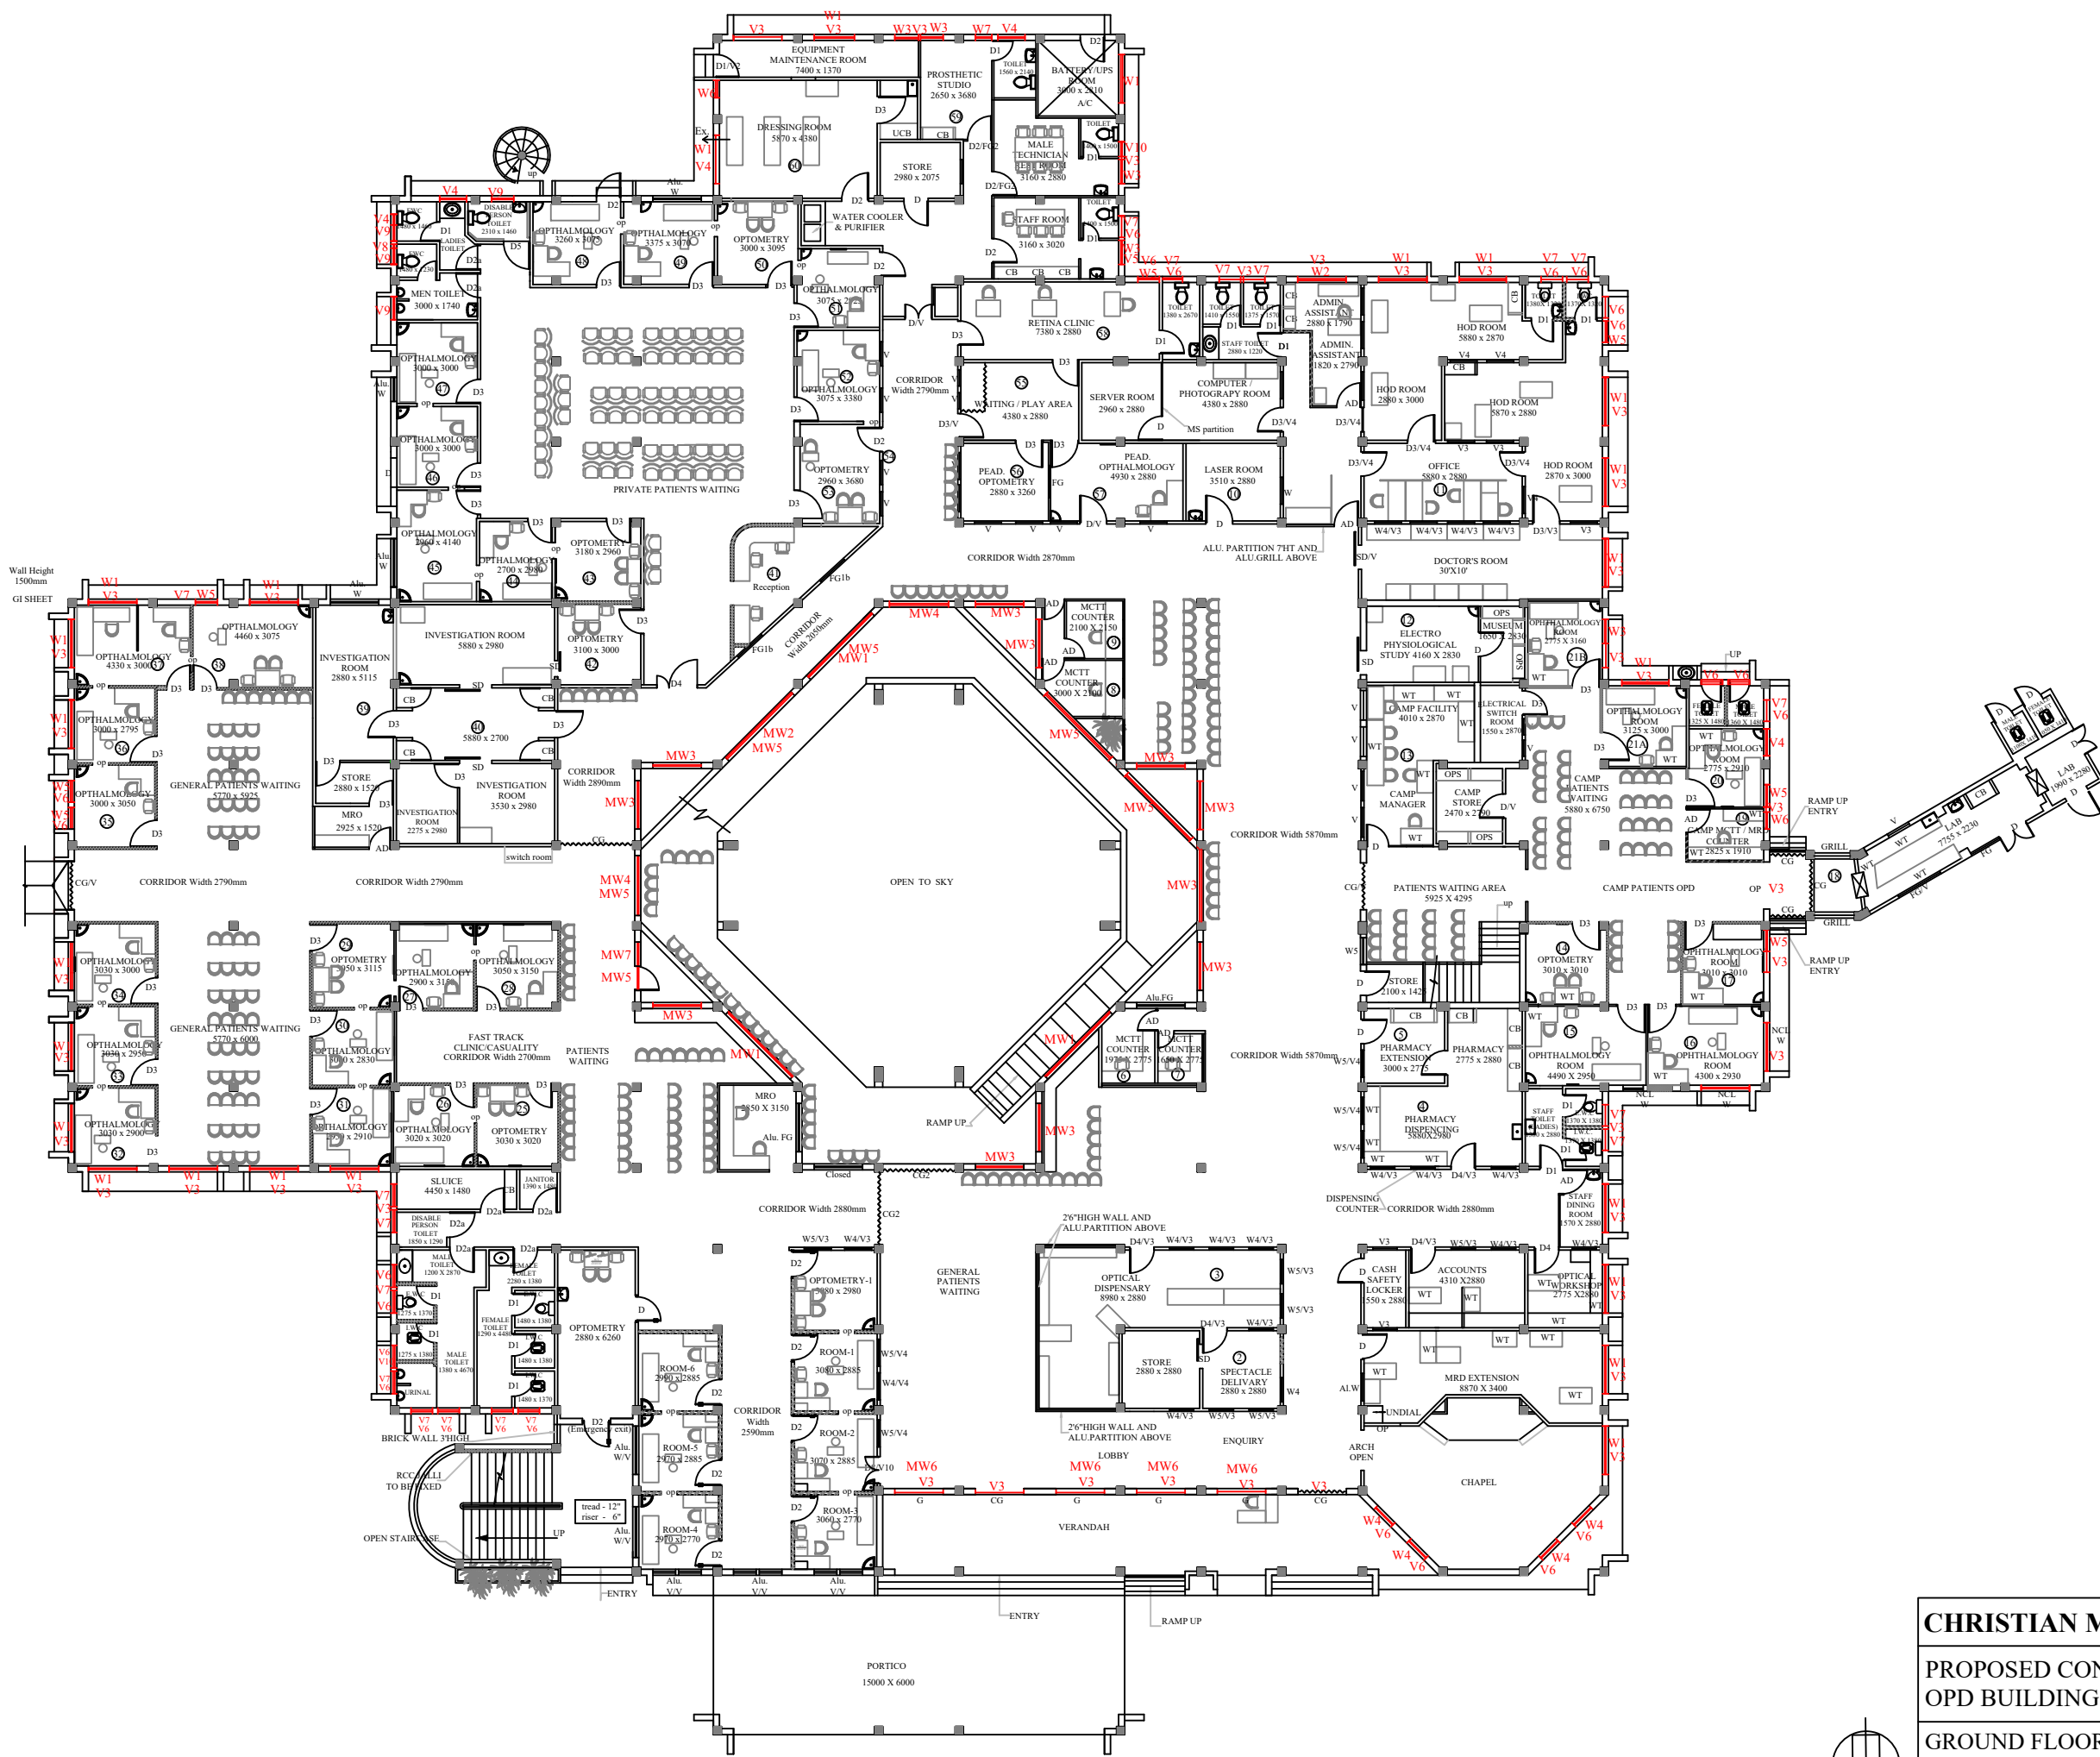

GROUND FLOOR PLAN
2713.25SQM /29194.57SQFT

JOINERY	
W1	1800 x 1350
W2	1800 x 900
W3	900 x 1350
W4	800 x 2000
W5	800 x 1350
W6	650 x 1350
W7	450 x 1350
V1	2900 x 900
V2	2700 x 450
V3	1800 x 450
V4	1000 x 450
V5	900 x 450
V6	800 x 450
V7	800 x 600
V8	750 x 450
V9	600 x 600
V10	550 x 450
MW1	2400 x 1200
MW2	2400 x 900
MW3	2100 x 1800
MW4	2100 x 1200
MW5	2100 x 750
MW6	1800 x 1800
MW7	900 x 1200

TENDER PURPOSE ONLY

CHRISTIAN MEDICAL COLLEGE-VELLORE

PROPOSED CONSTRUCTION OF SCHELL CAMPUS
OPD BUILDING AT CMC VELLORE CAMPUS.

GROUND FLOOR WINDOW AND VENTILATOR PLAN

CHECKED: KATHIR.S	DRG.NO : CMC/SH/OPDB/A-001	PLANNING ENGINEER:
DRAWN: DHINAKARAN.I	DATE:16/07/2026	