
 


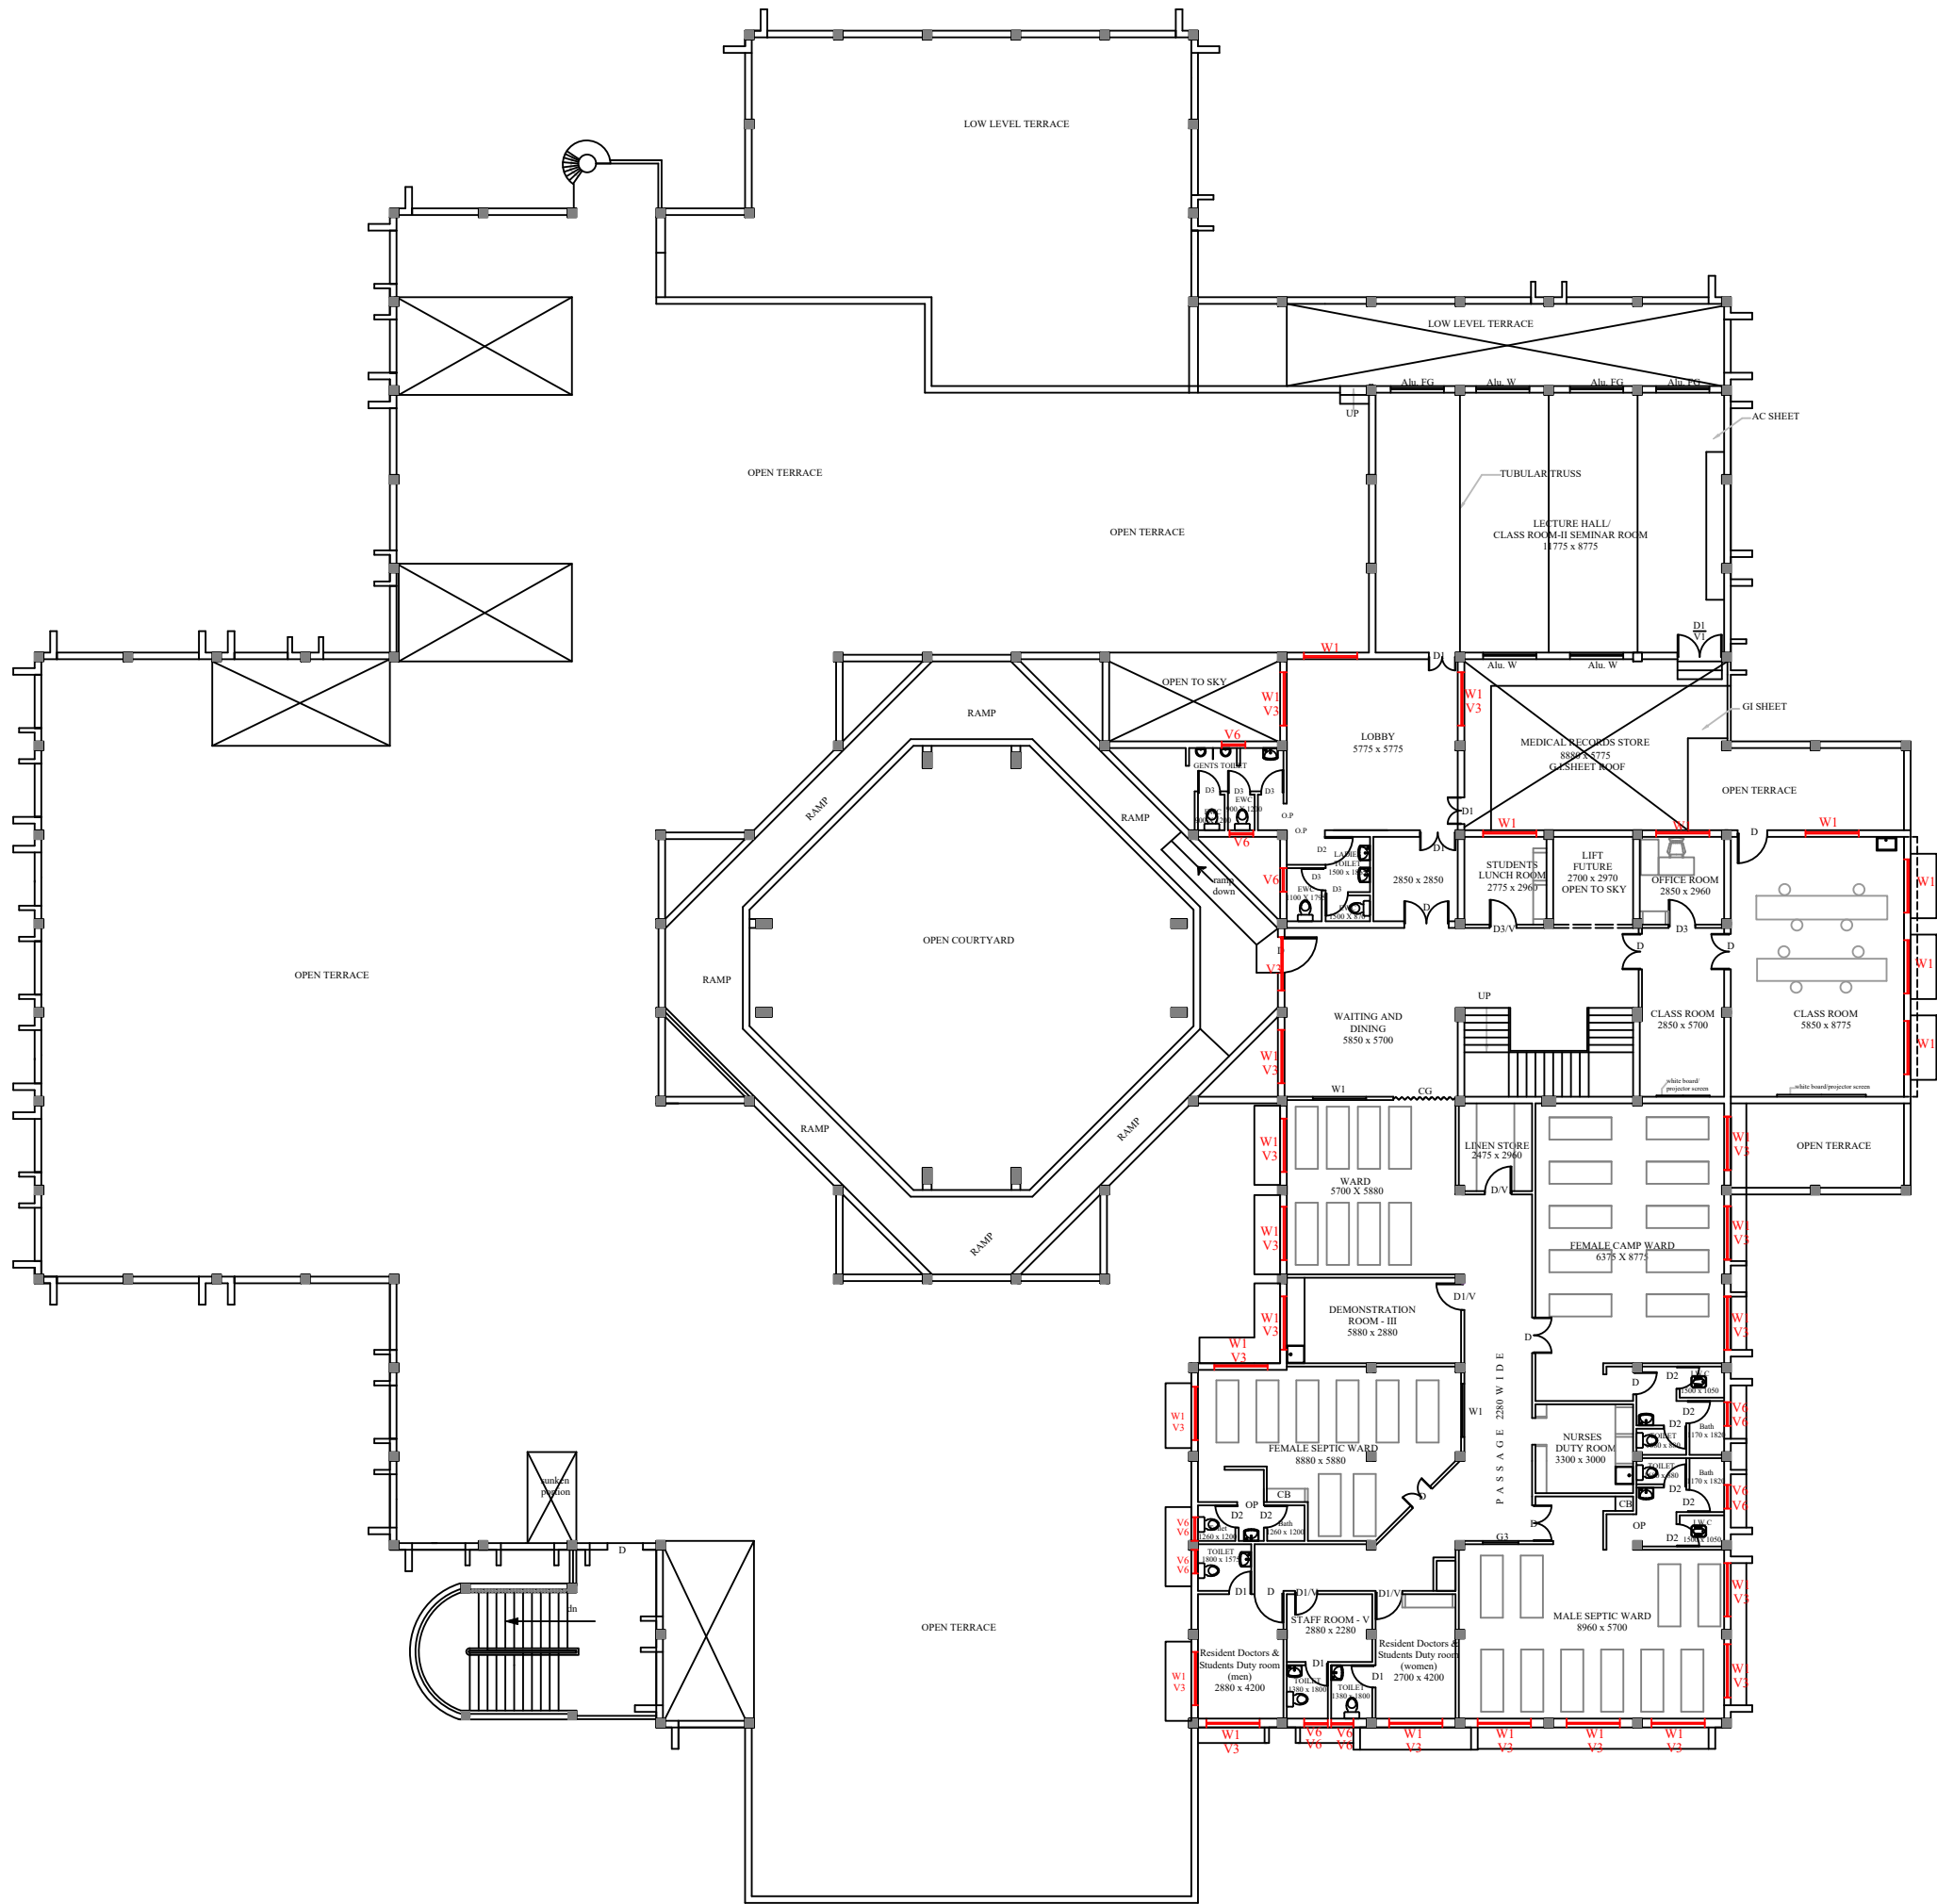

SECOND FLOOR PLAN
760.90SQM / 8187.28SQFT



TENDER PURPOSE ONLY		
CHRISTIAN MEDICAL COLLEGE-VELLORE		
PROPOSED CONSTRUCTION OF SCHELL CAMPUS OPD BUILDING AT CMC VELLORE CAMPUS.		
SECOND FLOOR WINDOW AND VENTILATOR PLAN		
CHECKED: KATHIR.S	DRG.NO : CMC/SH/OPDB/A-003	PLANNING ENGINEER:
DRAWN: DHINAKARAN.I	DATE:16/07/2026	